

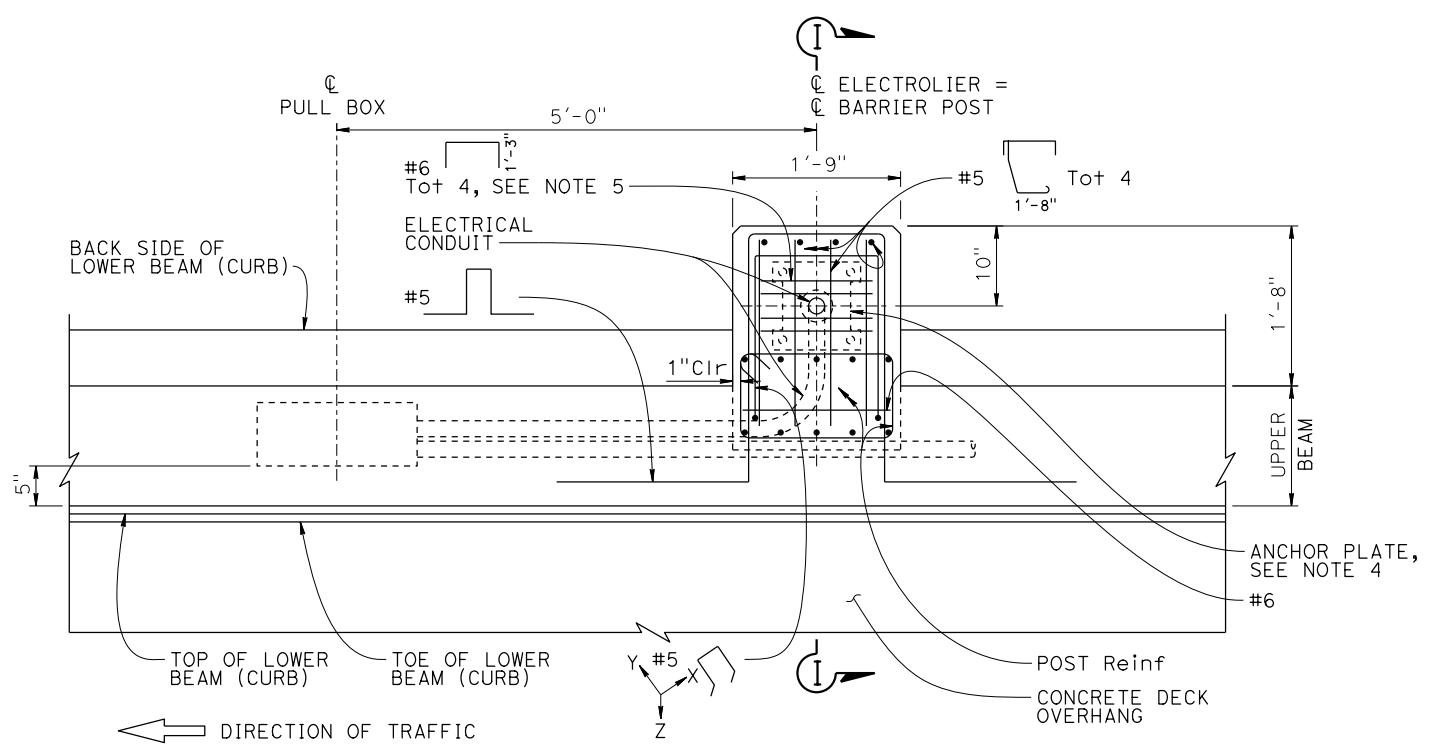


Dist	COUNTY	ROUTE	POST MILES TOTAL PROJECT	SHEET No.	TOTAL SHEETS
REGISTERED CIVIL ENGINEER			X	DATE	
PLANS APPROVAL DATE					
THE STATE OF CALIFORNIA OR ITS OFFICERS OR AGENTS SHALL NOT BE RESPONSIBLE FOR THE ACCURACY OR COMPLETENESS OF SCANNED COPIES OF THIS PLAN SHEET.					
THE REGISTERED CIVIL ENGINEER FOR THE PROJECT IS RESPONSIBLE FOR THE SELECTION AND PROPER APPLICATION OF THE COMPONENT DESIGN AND ANY MODIFICATIONS SHOWN.					

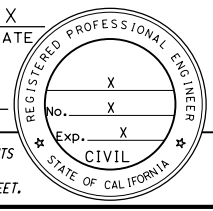


**PLAN**  
See Note 1.

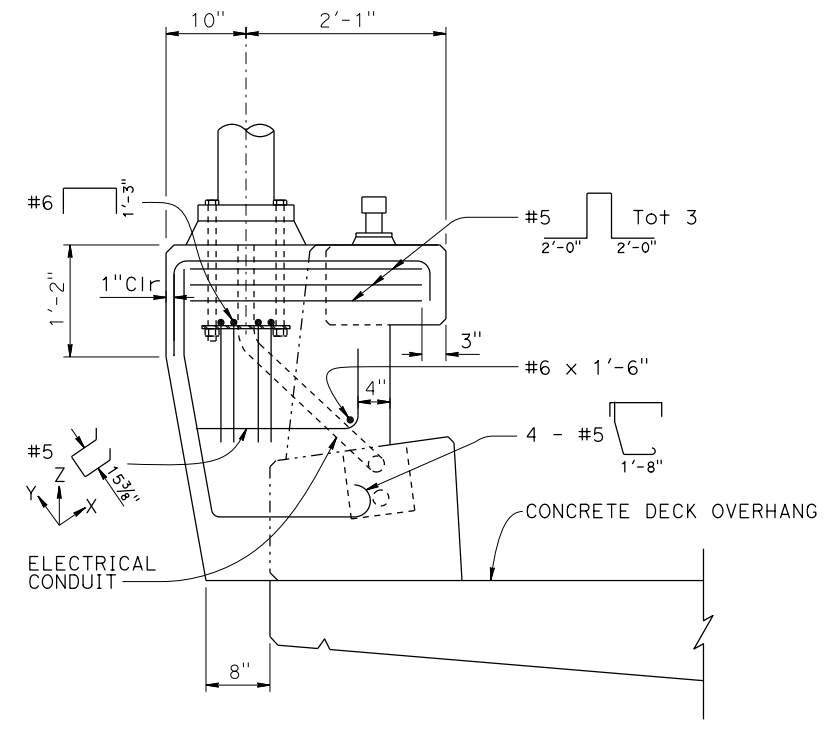


**SECTION I-I**  
See Note 4.

- NOTES:
- See ROADWAY PLANS for electrolier and pull box locations.
  - For electrical details, see Standard Plans ES-9A, ES-9B, ES-9C, ES-9D, and ES-9E.
  - Only the additional reinforcing for the electrolier pedestal and post reinforcement are shown. For other typical reinforcing for Type 86 Barrier, see "CONCRETE BARRIER TYPE 86 DETAILS No. 1", "CONCRETE BARRIER TYPE 86 DETAILS No. 2", and "CONCRETE BARRIER TYPE 86 DETAILS No. 3" sheets.
  - For electrolier mounting details, see Standards Plans ES-6A and ES-6B.
  - Place #6 reinforcement to clear conduit and anchor bolts.

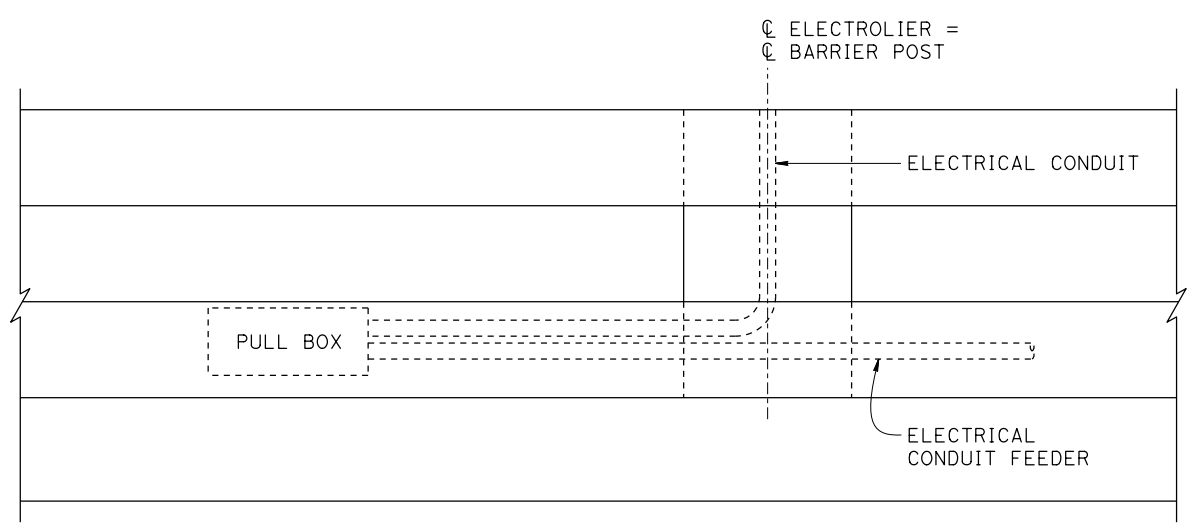

**ELEVATION**

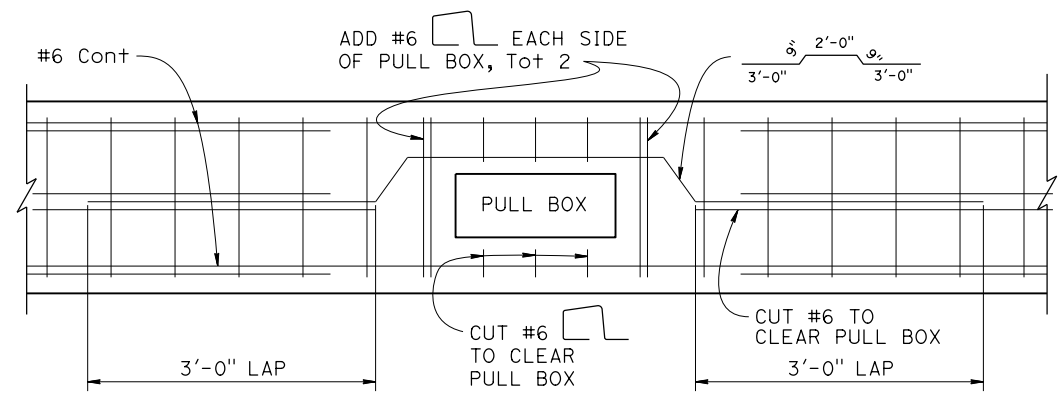

**PULL BOX REINFORCEMENT DETAILS**

**NO SCALE**

BRIDGE STANDARD DETAILS		The components of the Bridge Standard Details have been prepared under the responsible charge of the Technical Owner, a registered civil engineer in the State of California.	<b>STATE OF CALIFORNIA</b> DEPARTMENT OF TRANSPORTATION	<b>DIVISION OF ENGINEERING SERVICES</b>	BRIDGE No.	<b>X</b>	<b>CONCRETE BARRIER TYPE 86 DETAILS No. 5</b>			
<b>xs16-126-5</b> FILE NO.	April 2026 APPROVAL DATE				XX-XXXX POST MILE X.X					
Refer to: <a href="http://www.dot.ca.gov/hq/esc/techpubs/manual/bridgemanuals/bridge-standard-detail-sheets/index.html">http://www.dot.ca.gov/hq/esc/techpubs/manual/bridgemanuals/bridge-standard-detail-sheets/index.html</a>			DATE PLOTTED => 7-APR-2026 FILE => xs16-126-5.dgn	TIME PLOTTED => 14:40 USERNAME => s155182	ORIGINAL SCALE IN INCHES FOR REDUCED PLANS 0 1 2 3	UNIT: XXXX PROJECT NUMBER & PHASE: XXXXXXXXXX1	COUNTY/ROUTE/ZONE: XXX/XXX/X CONTRACT No.: XX-XXXXX4	DISREGARD PRINTS BEARING EARLIER REVISION DATES	REVISION DATES 10/17/21 04/07/26 03/25/26	SHEET OF X X